


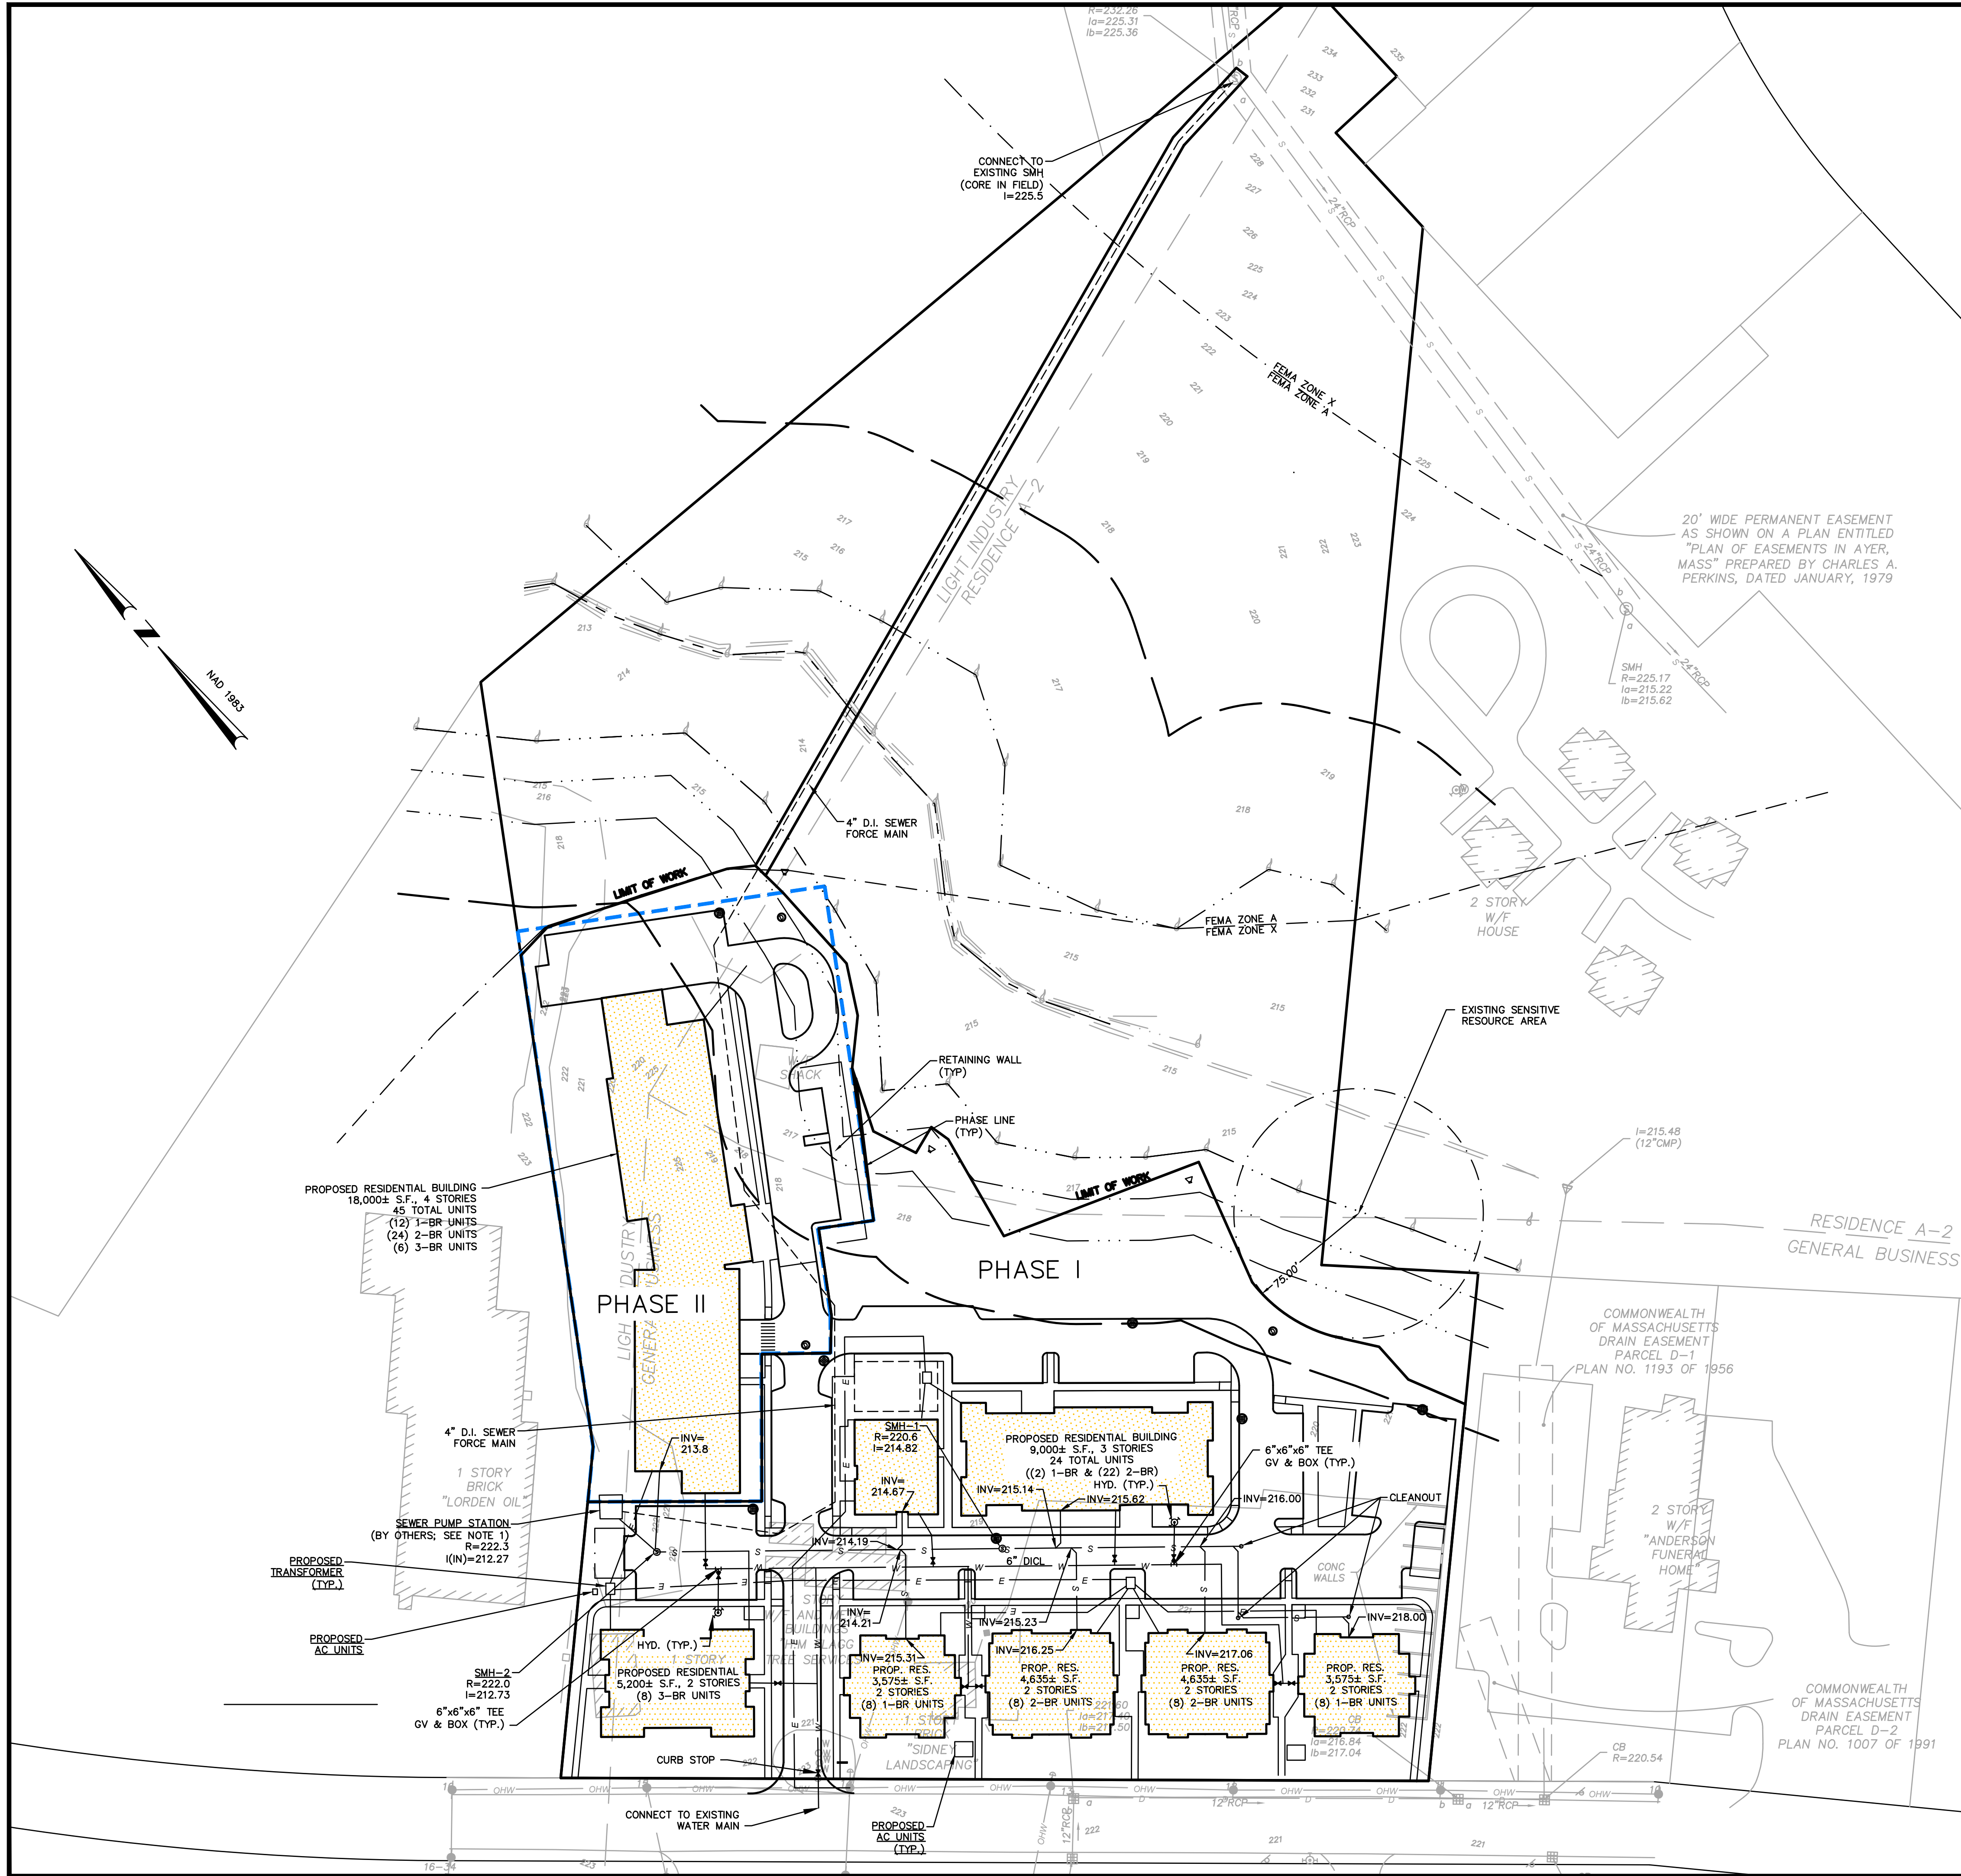

- NOTES:
- SEWER PUMP STATION DIMENSIONS AND DESIGN PARAMETERS ARE FOR EXAMPLE ONLY. CONTRACTOR SHALL CONFIRM ALL DESIGNS WITH MANUFACTURER.
 - PUMP DESIGN PARAMETERS (FOR EXAMPLE ONLY):
 - AVERAGE TOTAL DAILY FLOW: 21,785 GPD
 - PEAK TOTAL DAILY FLOW: 65,355 GPD
 - PUMP FLOW RATE (ASSUMED): 70 GPM
 - STATIC HEAD: *13.2 FT
 - MAX. TOTAL DYNAMIC HEAD: 34.2 FT
- *STATIC HEAD, NOT INCLUDING WET WELL DEPTH BELOW INVERT.

ISSUED FOR PERMITTING
NOT FOR CONSTRUCTION



PROFESSIONAL ENGINEER DATE

AYER COMMONS

65 FITCHBURG ROAD
IN
AYER
MASSACHUSETTS
(MIDDLESEX COUNTY)

UTILITY PLAN

JUNE 14, 2022

REVISIONS:		
NO.	DATE	DESC.
1	8/15/22	TOWN COMMENTS

PREPARED FOR:
NEIGHBORHOOD OF
AFFORDABLE HOUSING
143 BORDER STREET
EAST BOSTON, MA

BSC GROUP
300 Brickstone Square
Andover, Massachusetts
01810
617 896 4300

© 2022 BSC Group, Inc.
SCALE: 1" = 50'
0 25 50 100 FEET
FILE:
DWG.:
JOB. NO: 8-9926.01
SHEET C-104